

**CONTAINER PORT OPERATIONAL AREA PAVEMENT REHABILITATION
WILFRED “BOMBA” ALLICK MARINE PORT
ST. CROIX, U.S. VIRGIN ISLANDS**

This addendum modifies or interprets the proposal documents by additions, deletions, clarifications, corrections, or other type of modifications. Addenda will become part of the Contract Documents. Proposers, upon receiving addenda, shall insert same into the Proposal Documents.

It is required that this Addendum #1 be signed in the Acknowledgment of Receipt below, and attach the entire addendum (page 1) to the Proposal and become part of the Proposal.



Acknowledgment of Receipt by Bidder

ATTACHMENTS


- I.** General Information
- II.** Existing Site Electrical Record Drawing No. 4320-E4
- III.** Bid Document Pick-up Sign-in Sheets
- IV.** Pre-Bid Meeting Sign-in Sheet

I. GENERAL


- Bid Due date remains the same: Until 4:00 P.M., January 25, 2017. Immediately, followed by the Public Bid Opening at 4:15 P.M.

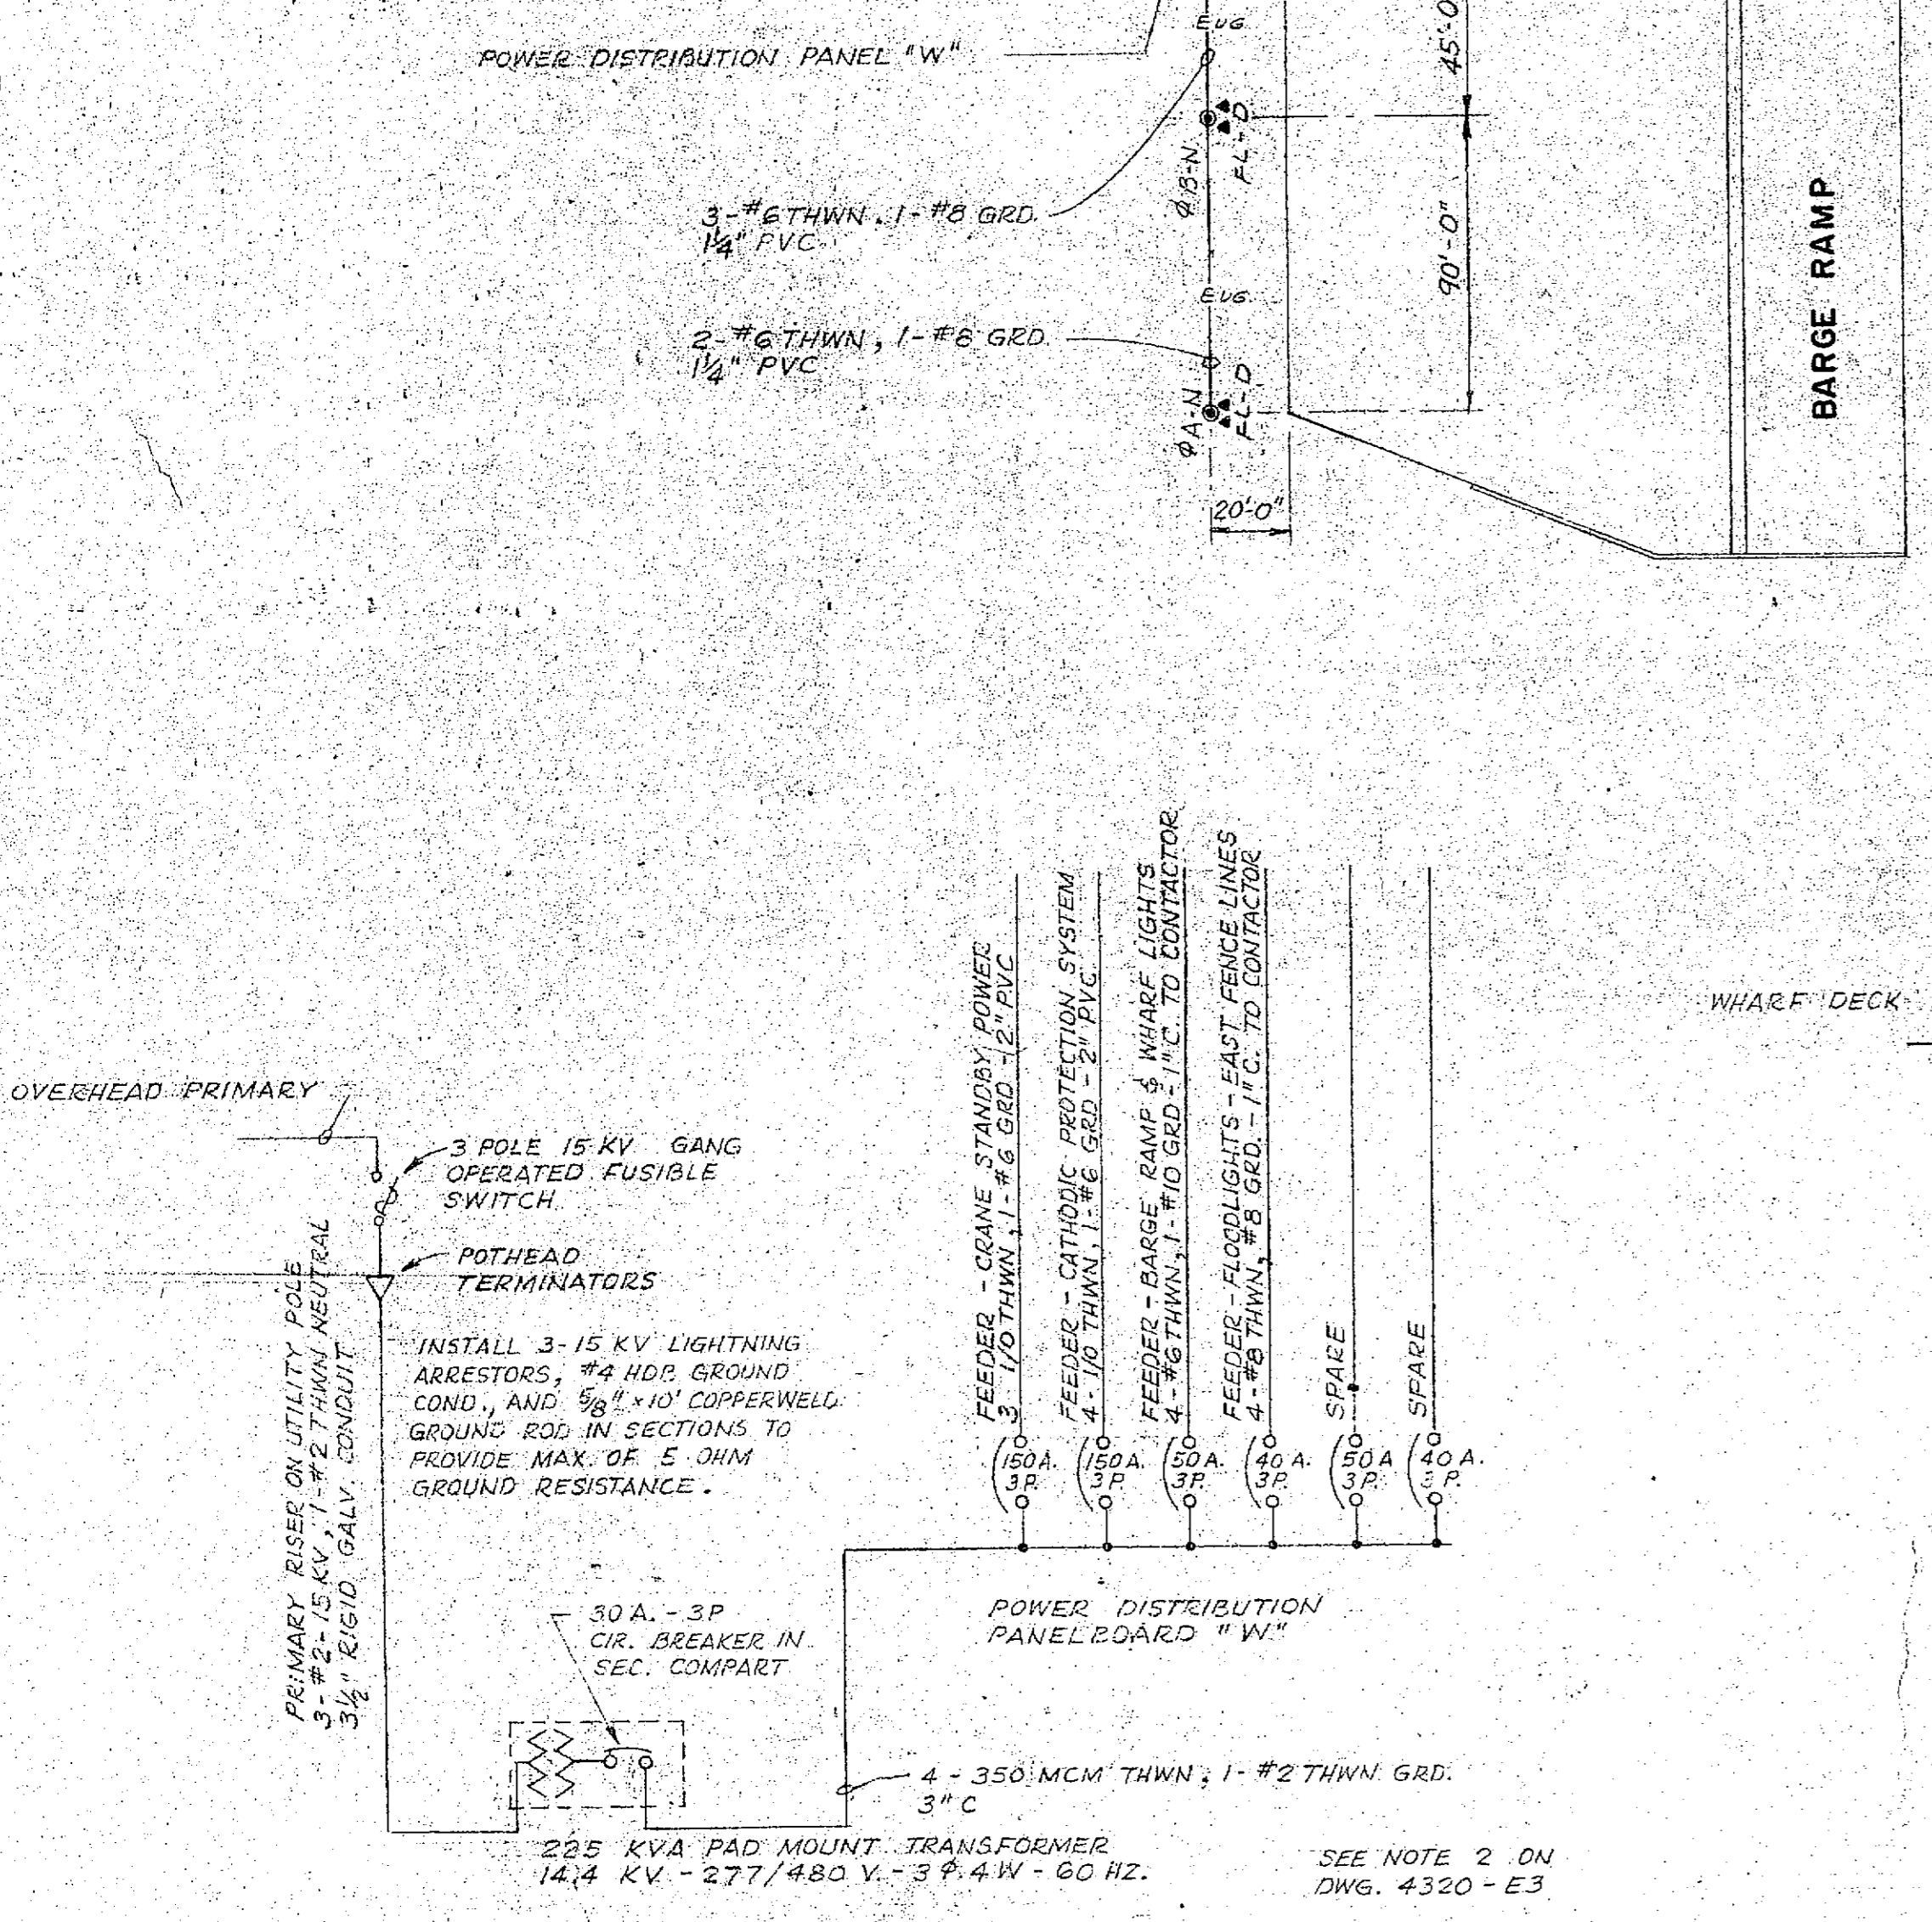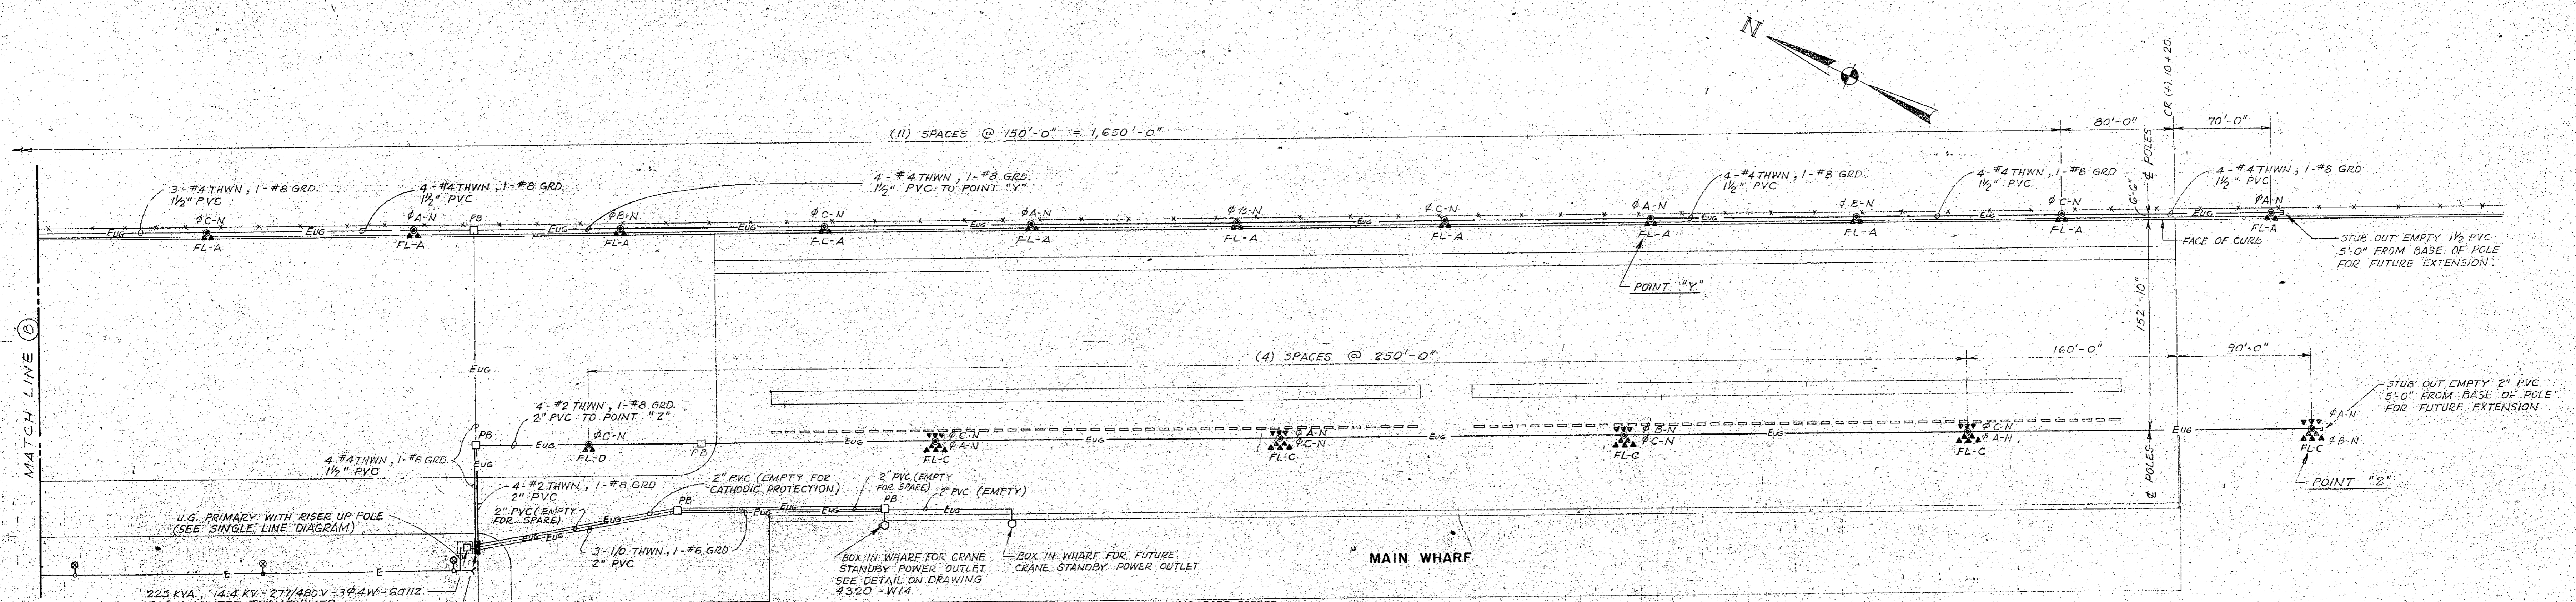


SINGLE LINE DIAGRAM

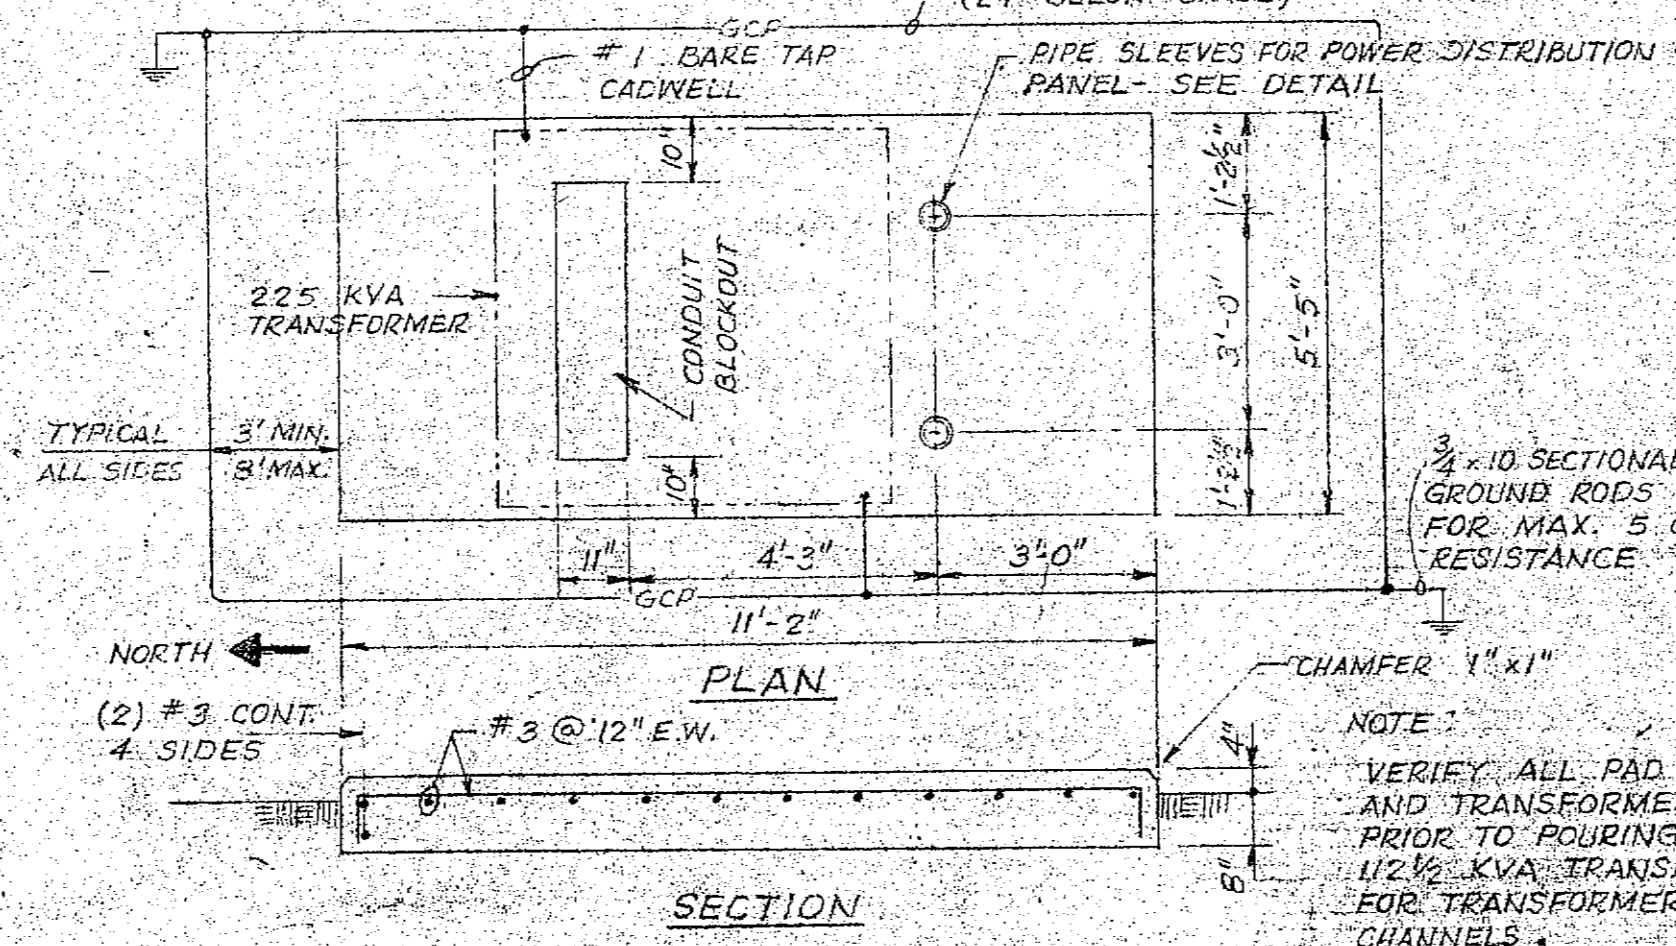

225 KVA TRANSFORMER PAD DETAIL

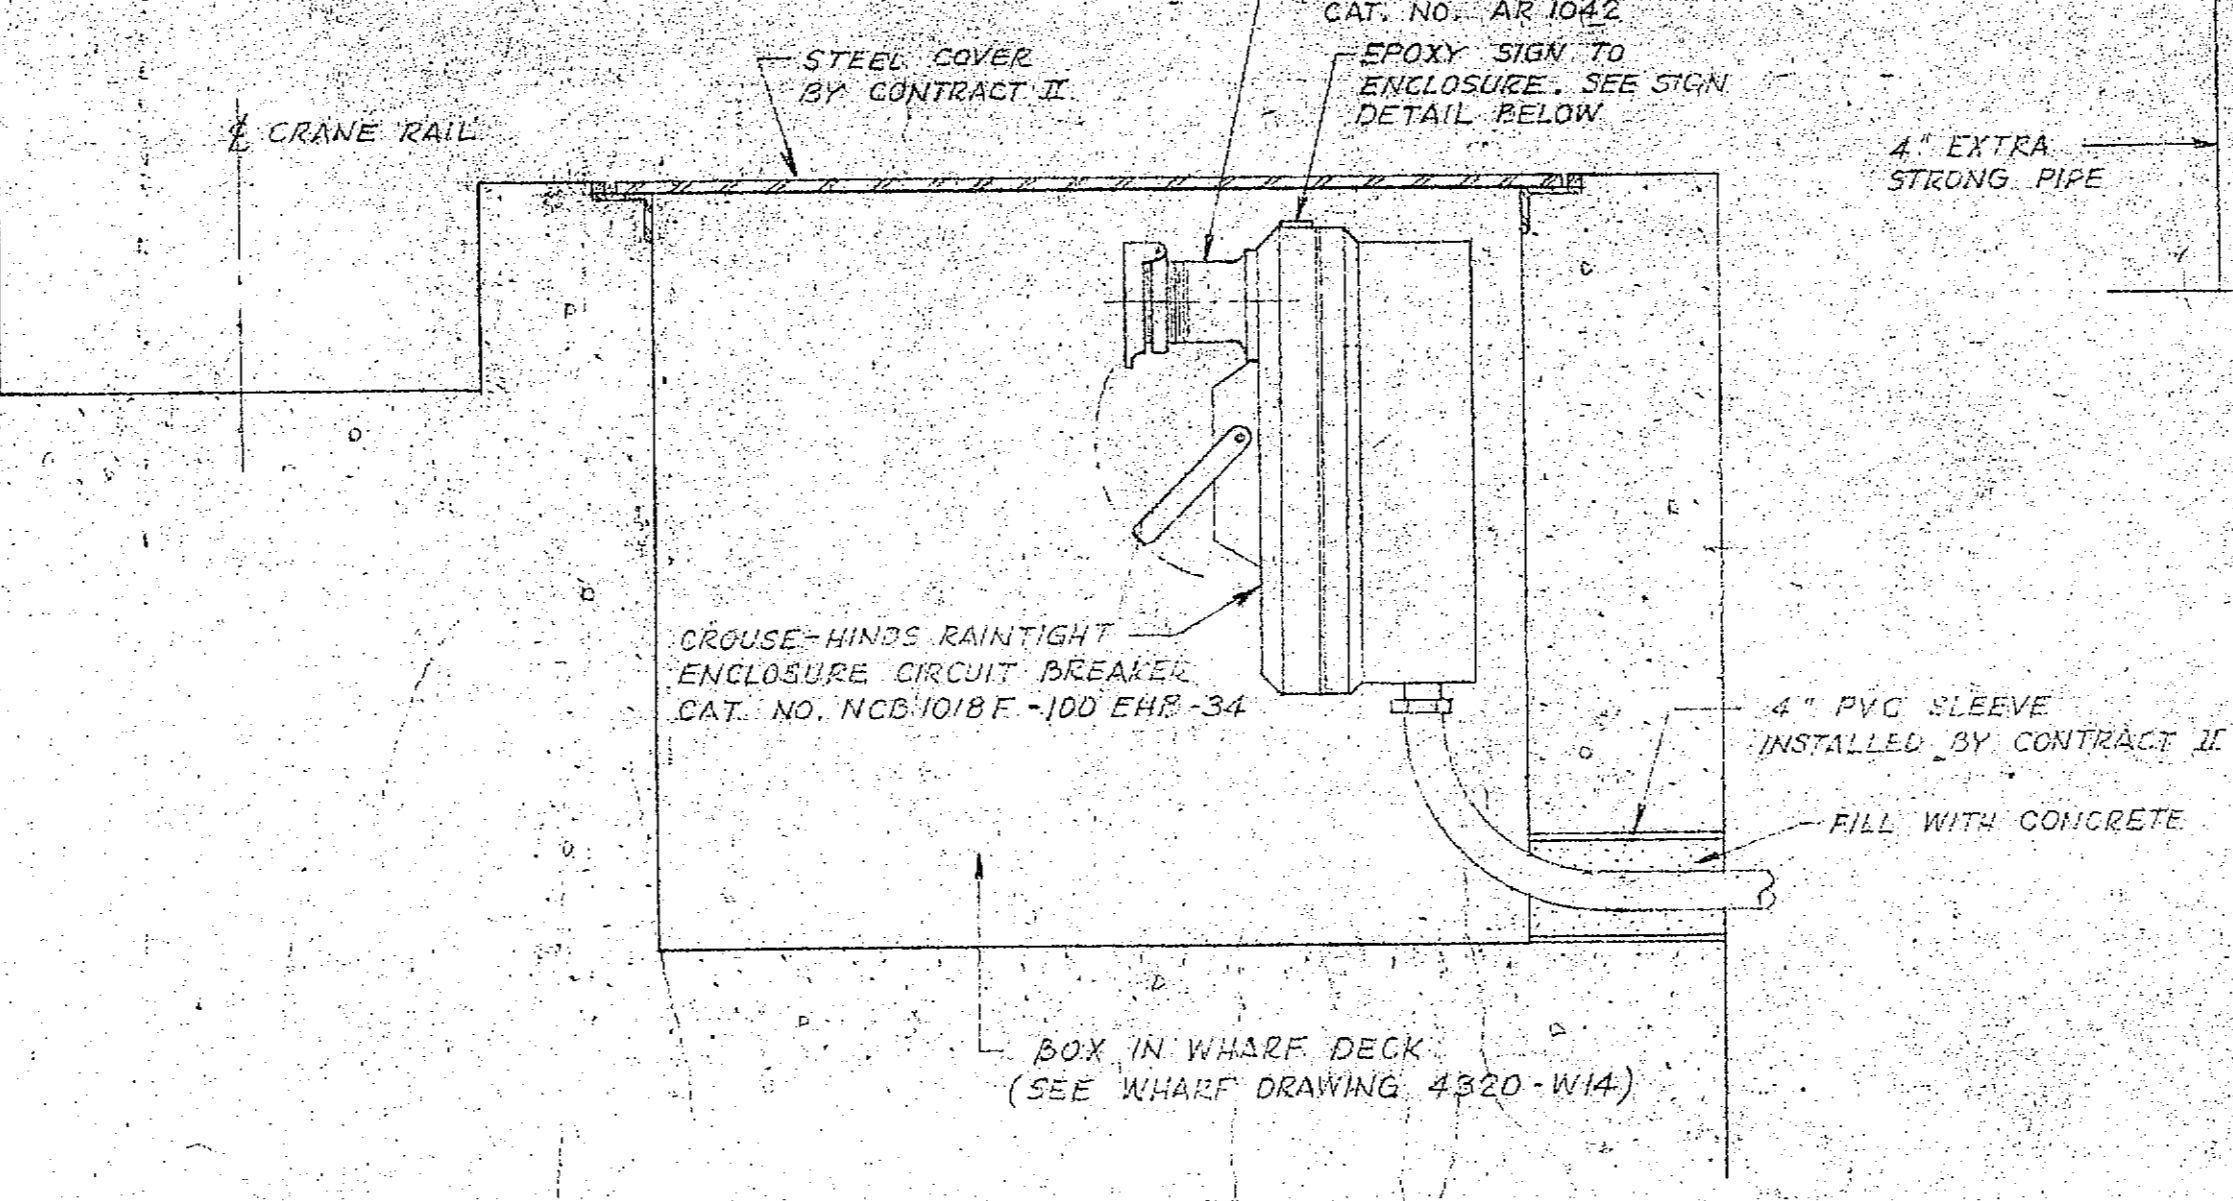

CRANE STANDBY POWER OUTLET

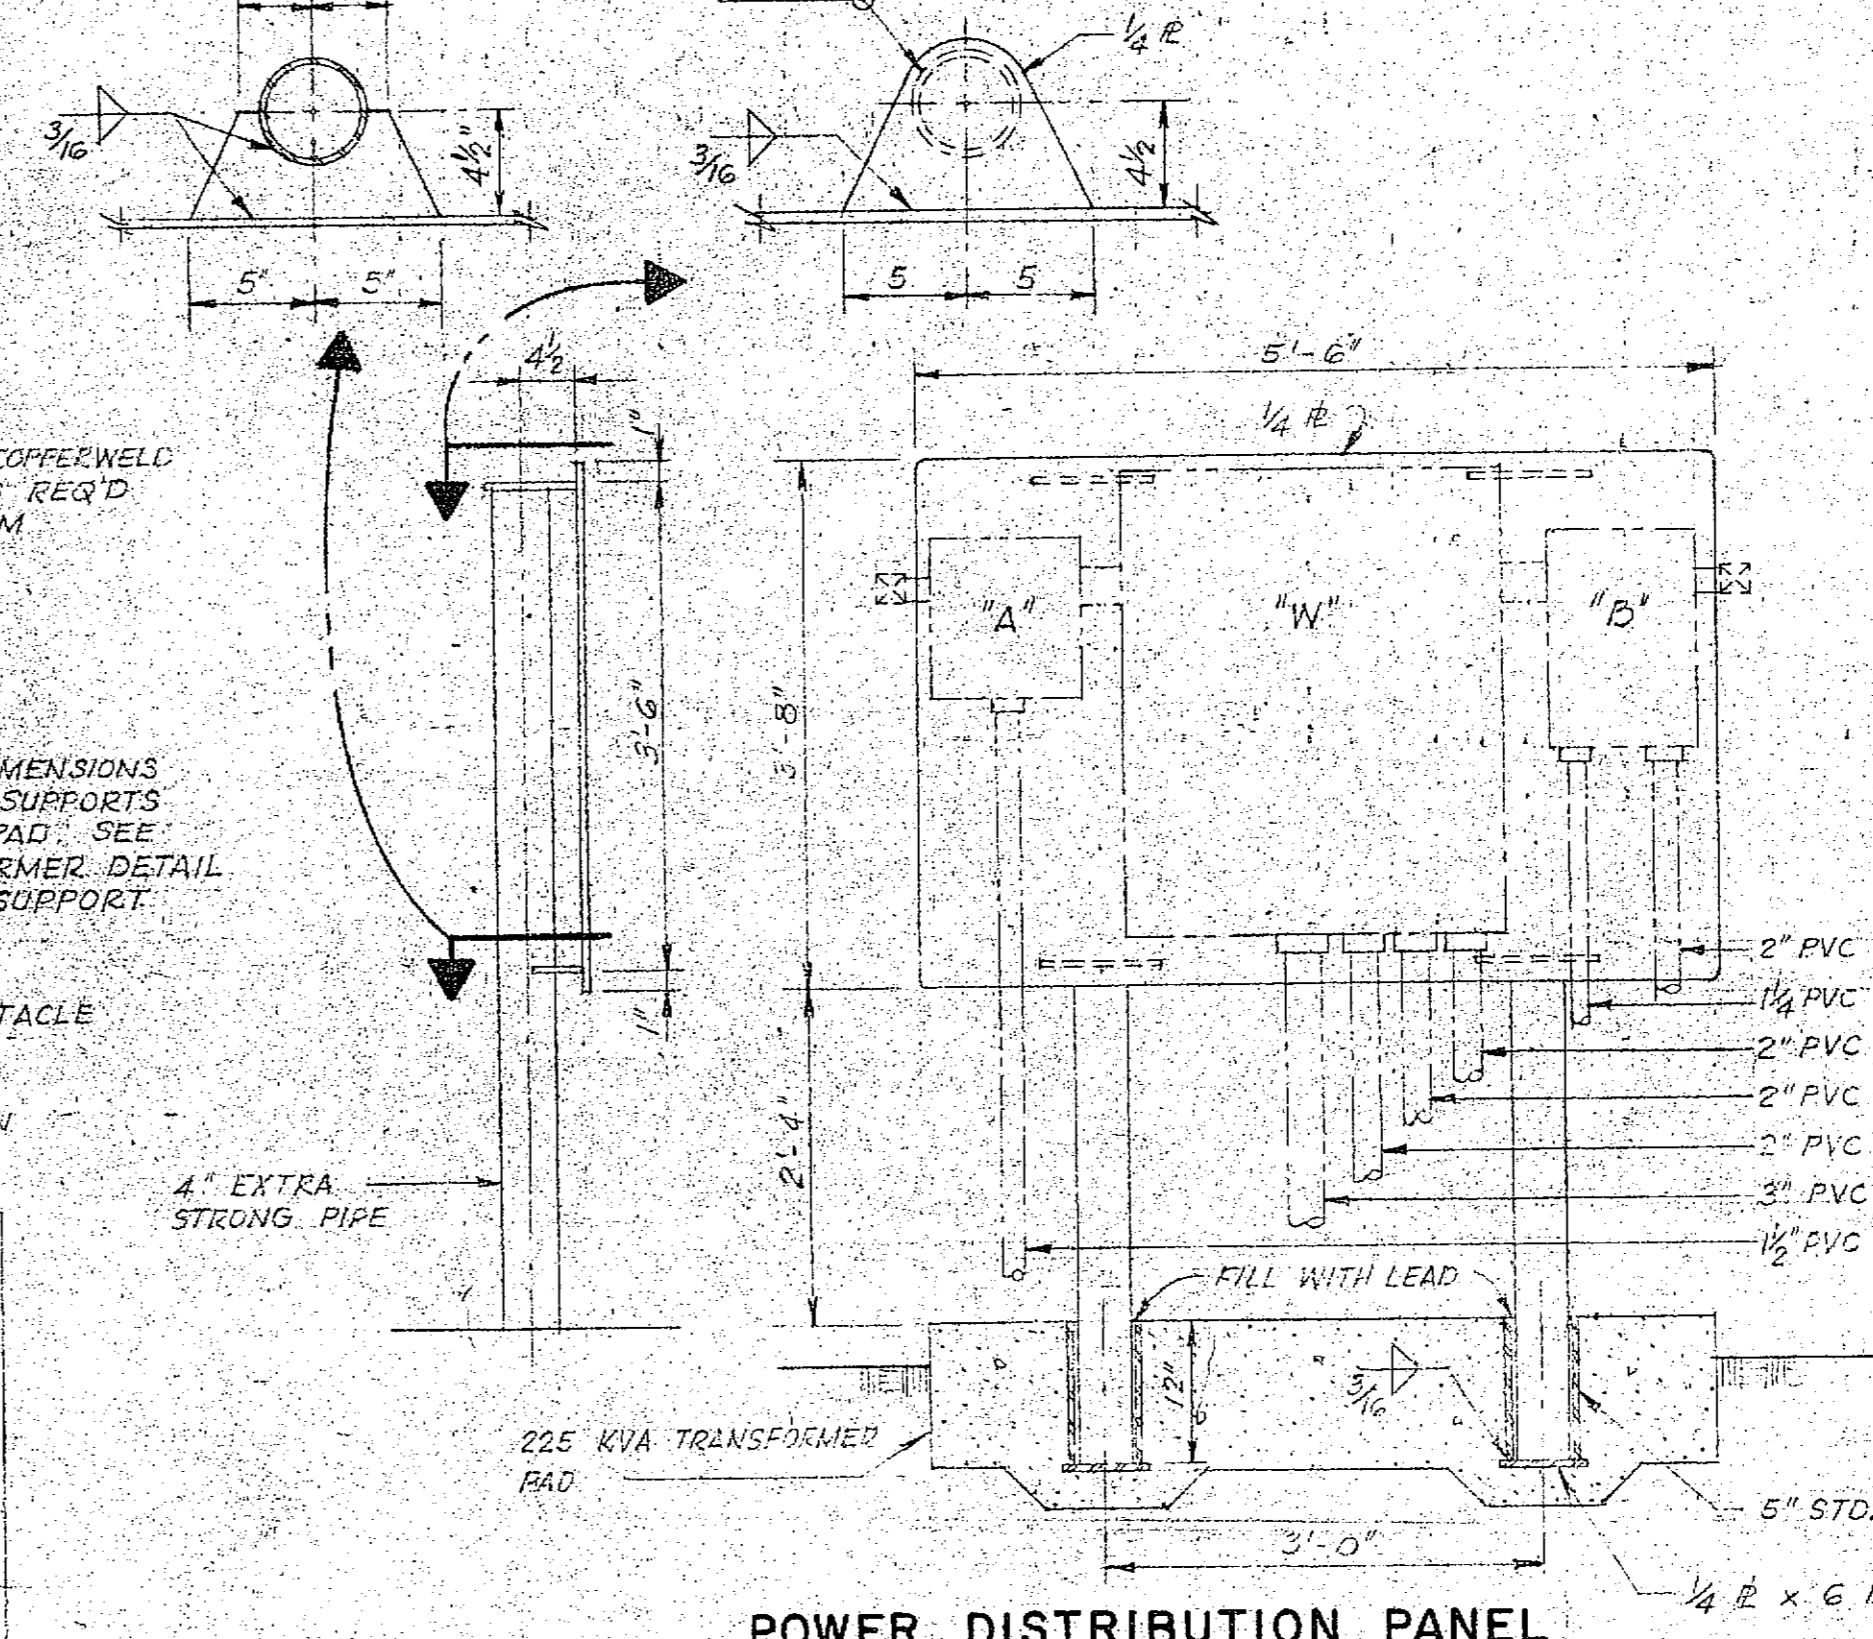

POWER DISTRIBUTION PANEL

DO NOT CONNECT OR DISCONNECT PORTABLE CABLE UNLESS HANDLE IS IN OFF POSITION (DOWN)

ENGRAVE WHITE LETTERS ON 1/8" BLACK PNEOLIC

SIGN DETAIL

SYMBOL LEGEND FOR POWER DISTRIBUTION PANEL

- | SYMBOL | DESCRIPTION |
|--------|---|
| "W" | POWER DISTRIBUTION PANEL 480/277 V, 4W, 3P WITH 400 A-3P MAIN LUGS ONLY, 2-150 A-3P, 2-50 A-3P, 2-40 A-3P BRANCH CIRCUITS. SQUARE D I-LINE IN WEATHERPROOF ENCLOSURE. |
| "A" | LIGHTING CONTACTOR FOR EAST FENCE LINE FLOODLIGHTS ASCO CAT. NO. 925PR9, 30A-480 V-3P-60 HZ WITH 277 V. COIL, MOUNTED IN NEMA II ENCLOSURE. |
| "B" | LIGHTING CONTACTOR FOR WHARF AND BARGE RAMP FLOODLIGHTS. ASCO CAT. NO. 926PR9, 60 A-480 V-3P-60 HZ WITH 277 VOLT COIL, MOUNTED IN NEMA II ENCLOSURE. |
| "S" | 20 A-1P-277 VOLT BY-PASS TOGGLE SWITCH MOUNTED IN "FS" CONDULET WITH WATERTIGHT COVER. |
| "PE" | PHOTO ELECTRIC CONTROL TORK CAT. NO. 2102, 277 V. SEE EXTERIOR LIGHTING CONTROL DIAGRAM DWG. 4320-E1 |

- 2" PVC TO WHARF LIGHTS
 - 1 1/2" PVC TO BARGE RAMP FLOODLIGHTS
 - 2" PVC TO CATHODIC PROTECTION SYSTEM
 - 2" PVC TO CRANE STANDBY POWER
 - 2" PVC TO WHARF (SPARE)
 - 3" PVC TO TRANSFORMER
 - 1 1/2" PVC TO EAST FENCE LINE FLOODLIGHTS
- NOTES**
- CONTRACTOR TO VERIFY ALL MOUNTING DIMENSIONS.
 - PIPE SLEEVES & POST TO BE HOT DIPPED GALVANIZED AFTER FABRICATION.

REV.	DATE	DESCRIPTION
C	10-15-80	REVISED FIXTURES, LAMPS & POLES
B	2-22-80	MISCELLANEOUS REVISIONS
A	1-18-80	DRAWING COMPLETE

HESS OIL VIRGIN ISLANDS CORP.

HESS

ST. CROIX U.S. VIRGIN ISLANDS

EWING, CAMPBELL & GOTTLIEB CONSULTING ENGINEERS	CONTAINER PORT
MOBILE NEW ORLEANS	OUTSIDE ELECTRICAL
Checked By: EMD Approved: [Signature] V.I. PERM. NO. T-169	AREA C
Scale: 1" = 50'	DRAWING NO. 4320-E4



BID DOCUMENT PICK-UP

Sign-in Sheet

OPERATIONAL AREA PAVEMENT REHABILITATION

WILFED "BOMBA" ALLICK MARINE PORT

St. Croix, U.S. Virgin Islands

VIPA CER Project No. C2014-49

Location: Henry E. Rohlsen Airport
Virgin Islands Port Authority
Purchasing Department

Owner: Virgin Islands Port Authority

Print Name	Company Name	Contact Phone	Email
Chanda Coui	Marco St. Croix	(340) 778-1035	marcostcroix@gmail.com
Eason Jeffers	Quantum Vision Const.	(340) 227-1191	EASONJEFFERS@QUANTUMVISIONCONSTRUCTION.COM
JACOB HAYMAN	ATC, LLC	340-478-2100	JACOB.HAYMAN@ATC.VI
GEORGE LEPES	VIPAVINE	778-5220	VIPAVINE.COM
Kirwyn Figaro	Eleven Constr.	340.513.8722	KirwynFig@gmail.com
RICARDO NATER	ATC.	787-312-7621	RNATER@AIRECO.COM



PRE-BID CONFERENCE

Sign-in Sheet

Operational Area Pavement Rehabilitation

**WILFRED "BOMBA" ALLICK MARINE FACILITY
St. Croix, U.S. Virgin Islands
VIPA CER Project No. C2014-49**

Location: Henry E. Rohlsen Airport
Virgin Islands Port Authority
Terminal Conference Room

Time: 11:00 AM

Date: Thursday, January 12, 2017
Owner: Virgin Islands Port Authority

Print Name	Company Name	Contact Phone	Email
VANIS AURELLIENS	VIPA	778.3757	vaurelien@viport.com
FRITZGERALD BOEZEM	VIPA	778.1012	fboezem@viport.com
Kerwyn Augustin	MARCO	340-778-1035	marcosterdix@gmail.com
Monique Hendricks	VIPA	778-9696	mhendricks@vipa.com
Shawn Baptiste	marco	513-2218	marco.walter@vipa.com
Franklyn Victor	Running Cust.	514 2788	Fymaint@Hotmail.com
Mark Grimes	Custom Builders	775-2605	MGrimes@custombuilders-vi.com
Rafael Hernandez	A.T. Construction	(787) 615-1924	rahernandez@airteks.com