

**CONTAINER PORT OPERATIONAL AREA PAVEMENT REHABILITATION  
WILFRED “BOMBA” ALLICK MARINE PORT  
ST. CROIX, U.S. VIRGIN ISLANDS**

This addendum modifies or interprets the proposal documents by additions, deletions, clarifications, corrections, or other type of modifications. Addenda will become part of the Contract Documents. Proposers, upon receiving addenda, shall insert same into the Proposal Documents.

It is required that this Addendum #1 be signed in the Acknowledgment of Receipt below, and attach the entire addendum (page 1) to the Proposal and become part of the Proposal.

---







Acknowledgment of Receipt by Bidder

**ATTACHMENTS**

- I.** General Information
- II.** Existing Site Electrical Record Drawing No. 4320-E4
- III.** Bid Document Pick-up Sign-in Sheets
- IV.** Pre-Bid Meeting Sign-in Sheet

**I. GENERAL**

- Bid Due date remains the same: Until 4:00 P.M., January 25, 2017. Immediately, followed by the Public Bid Opening at 4:15 P.M.

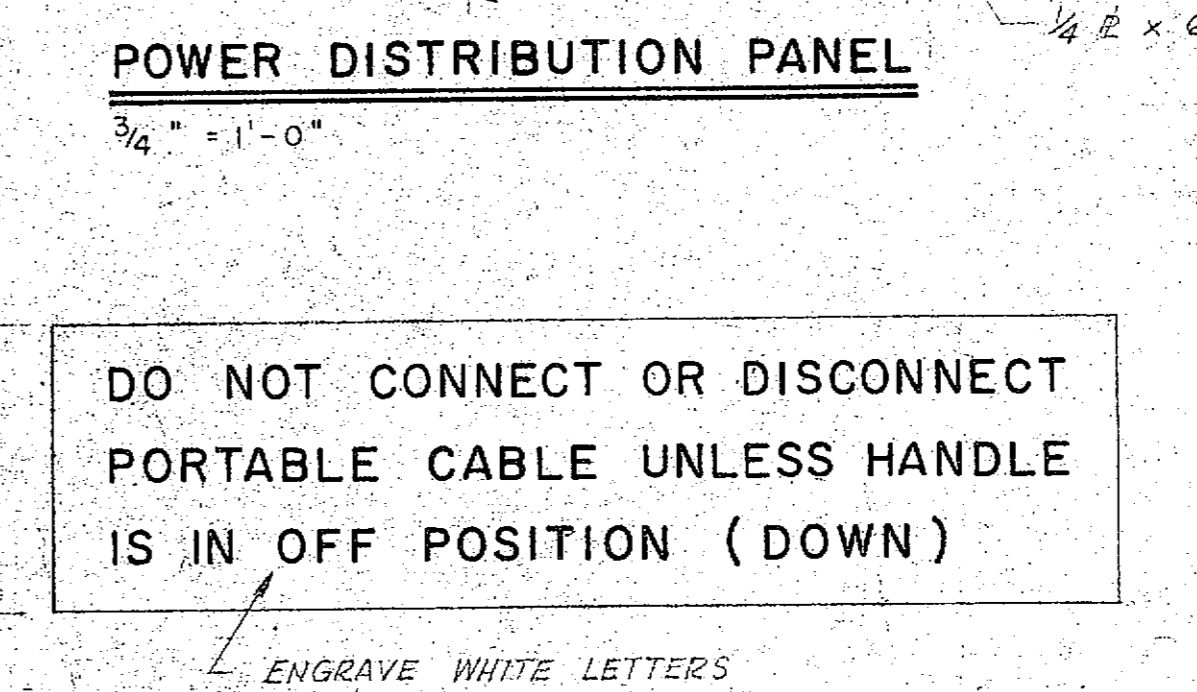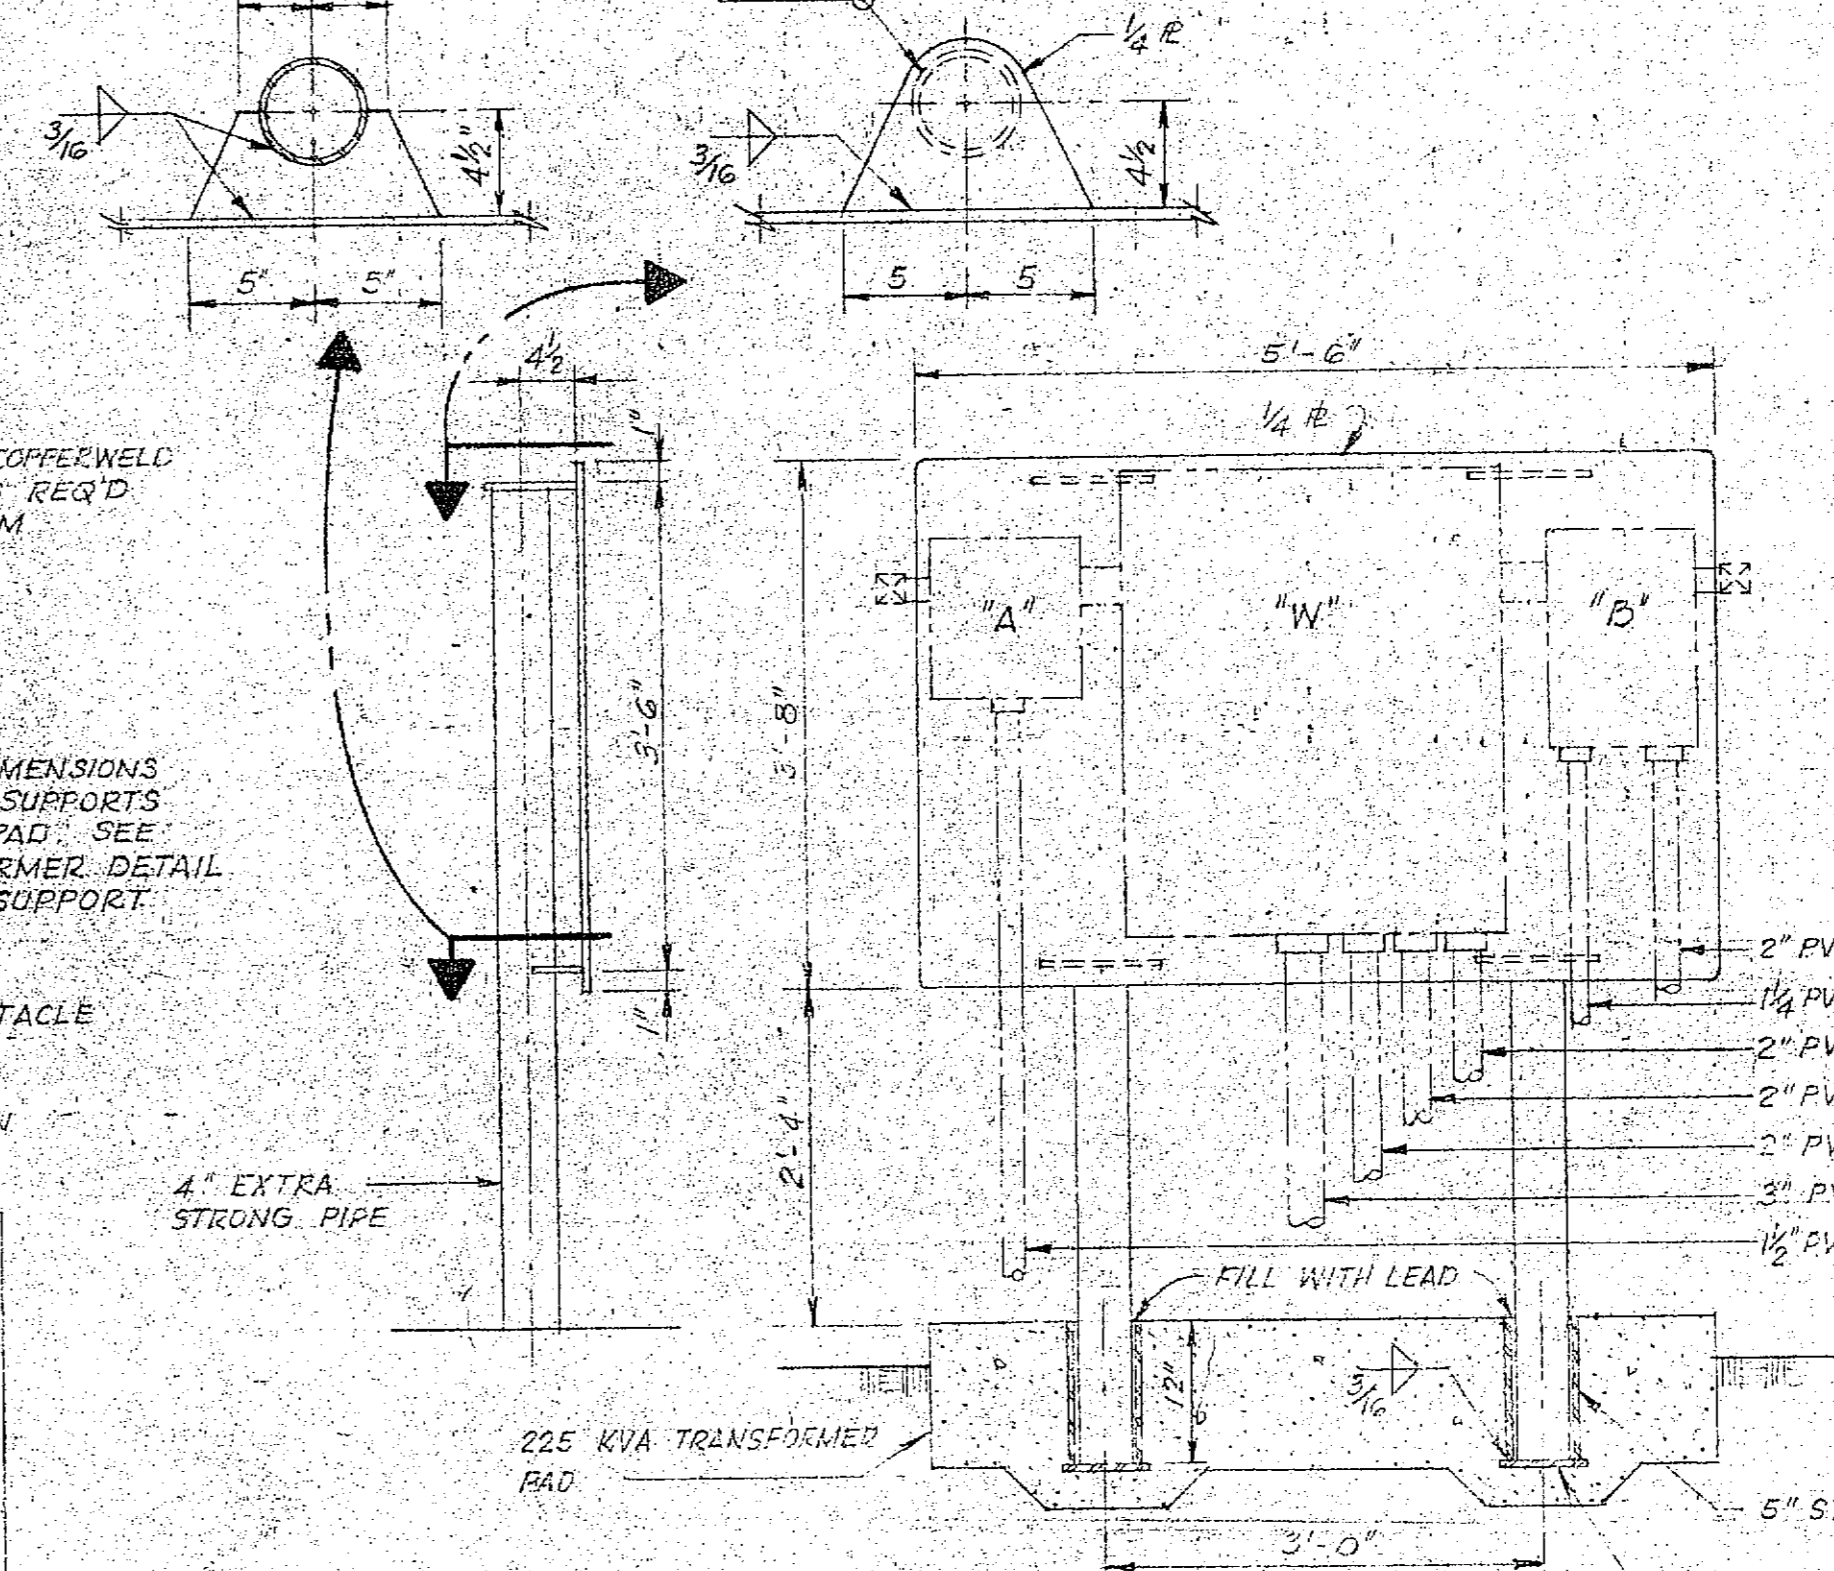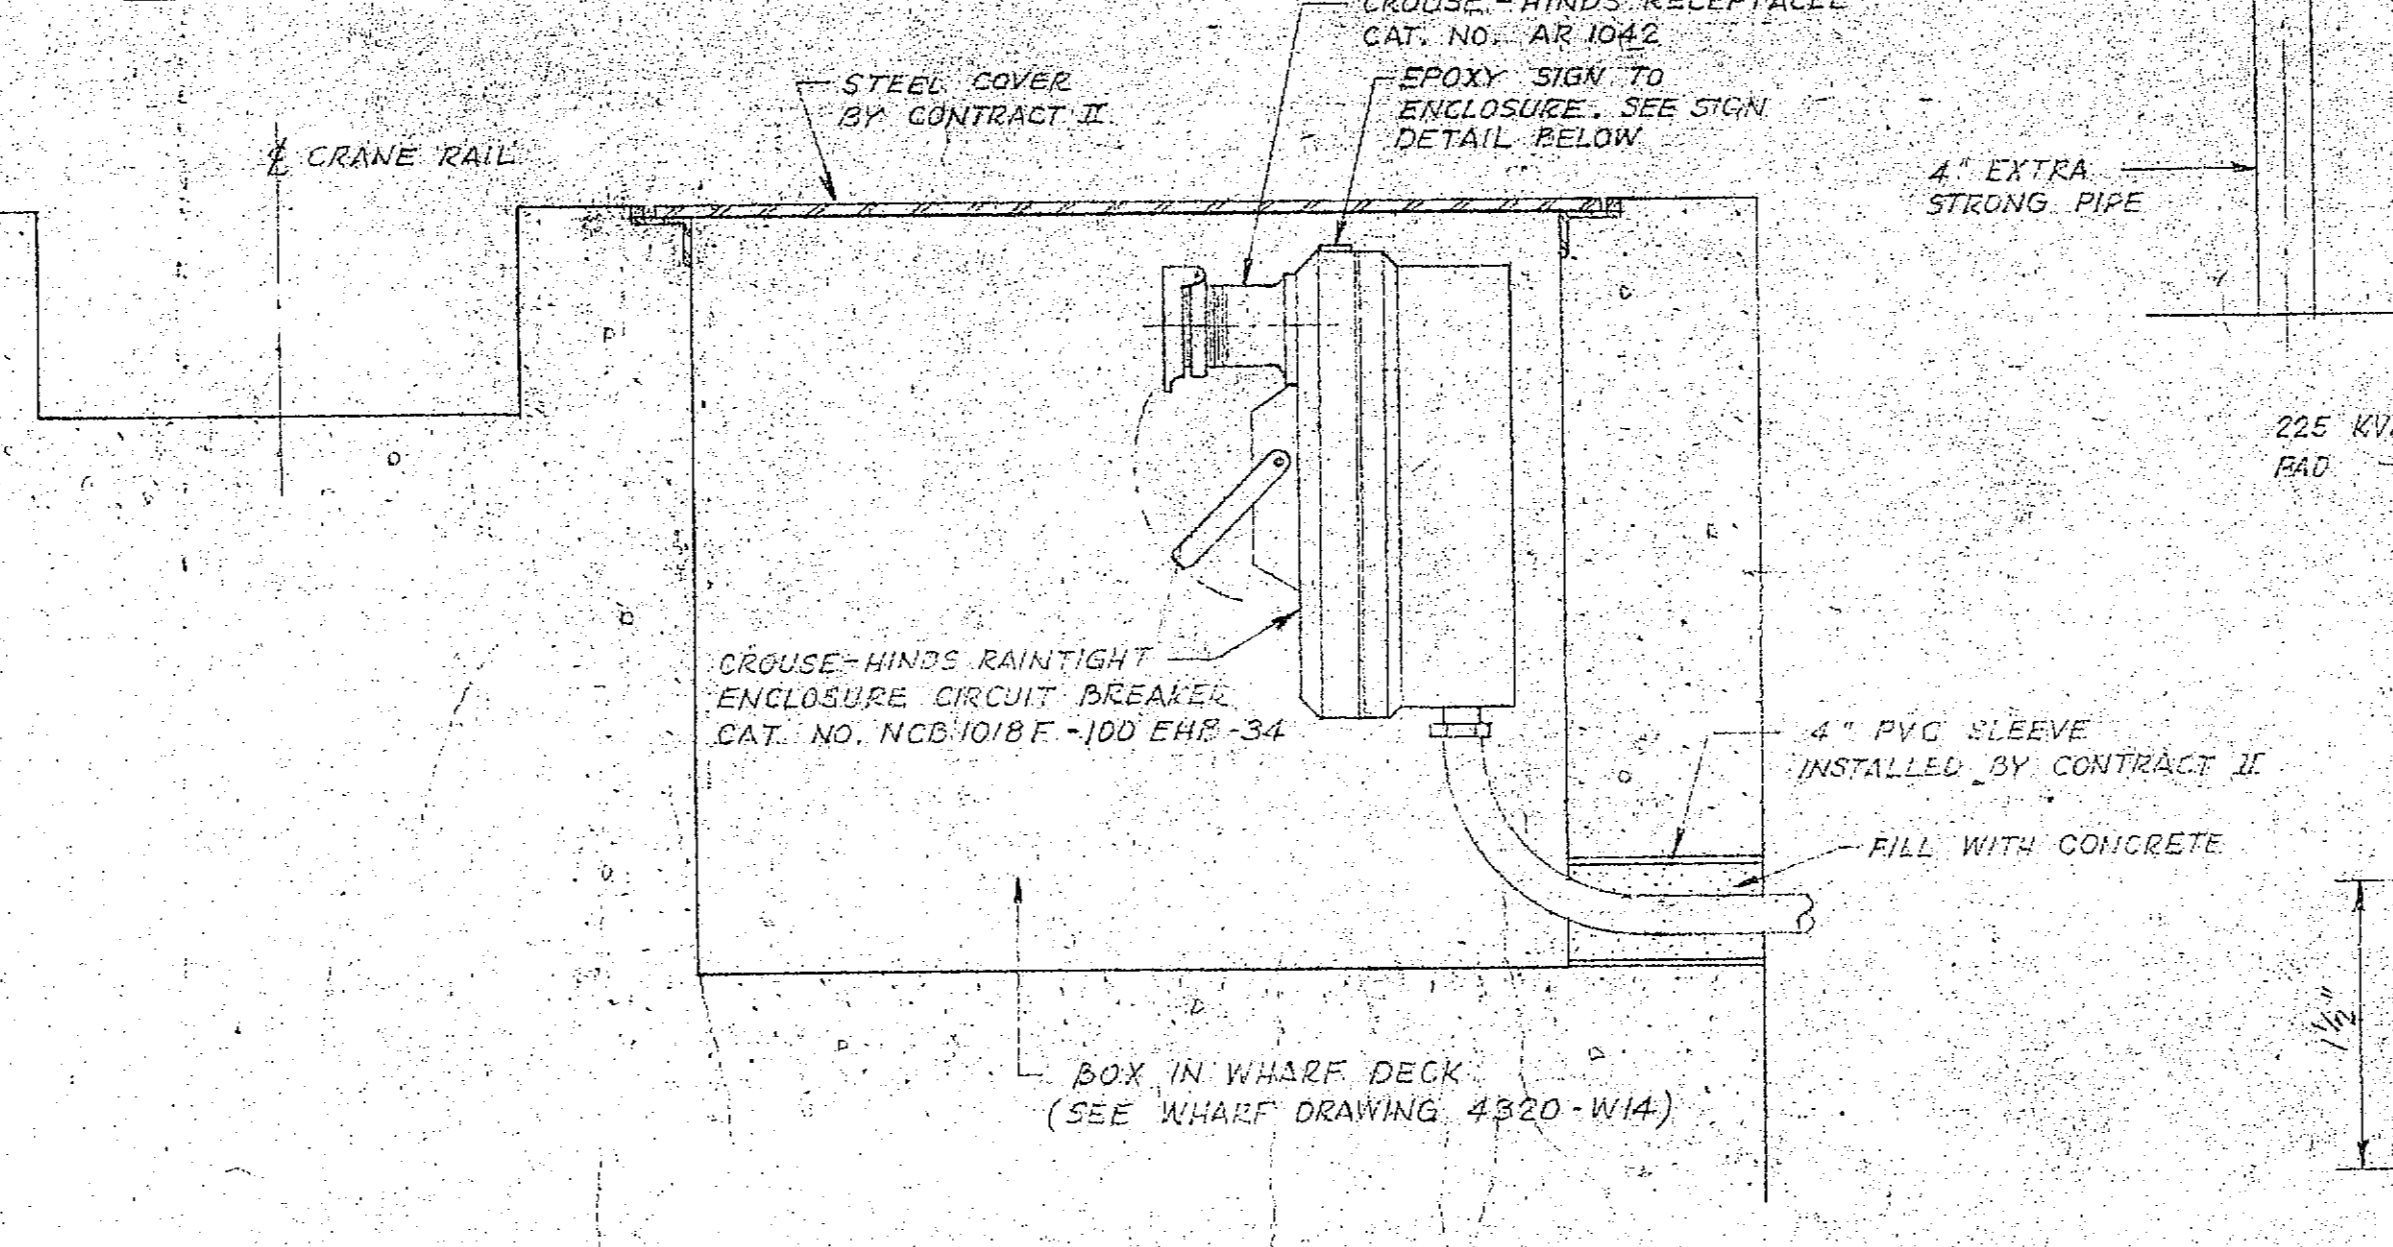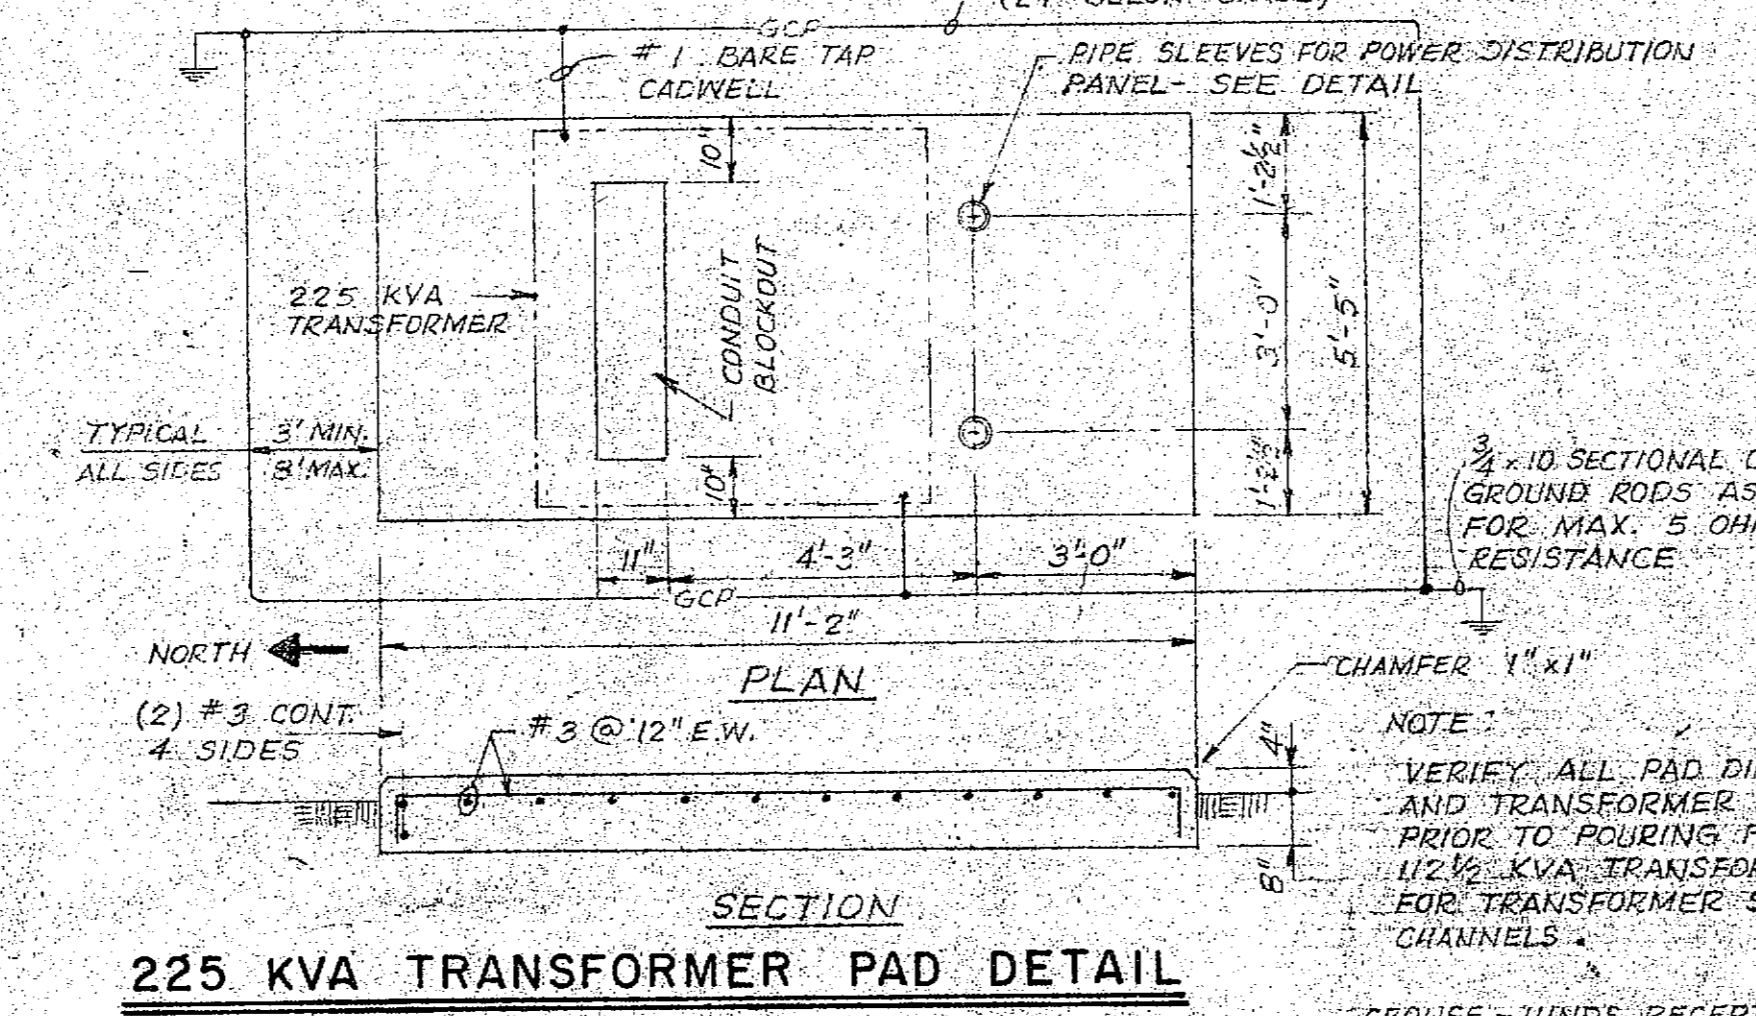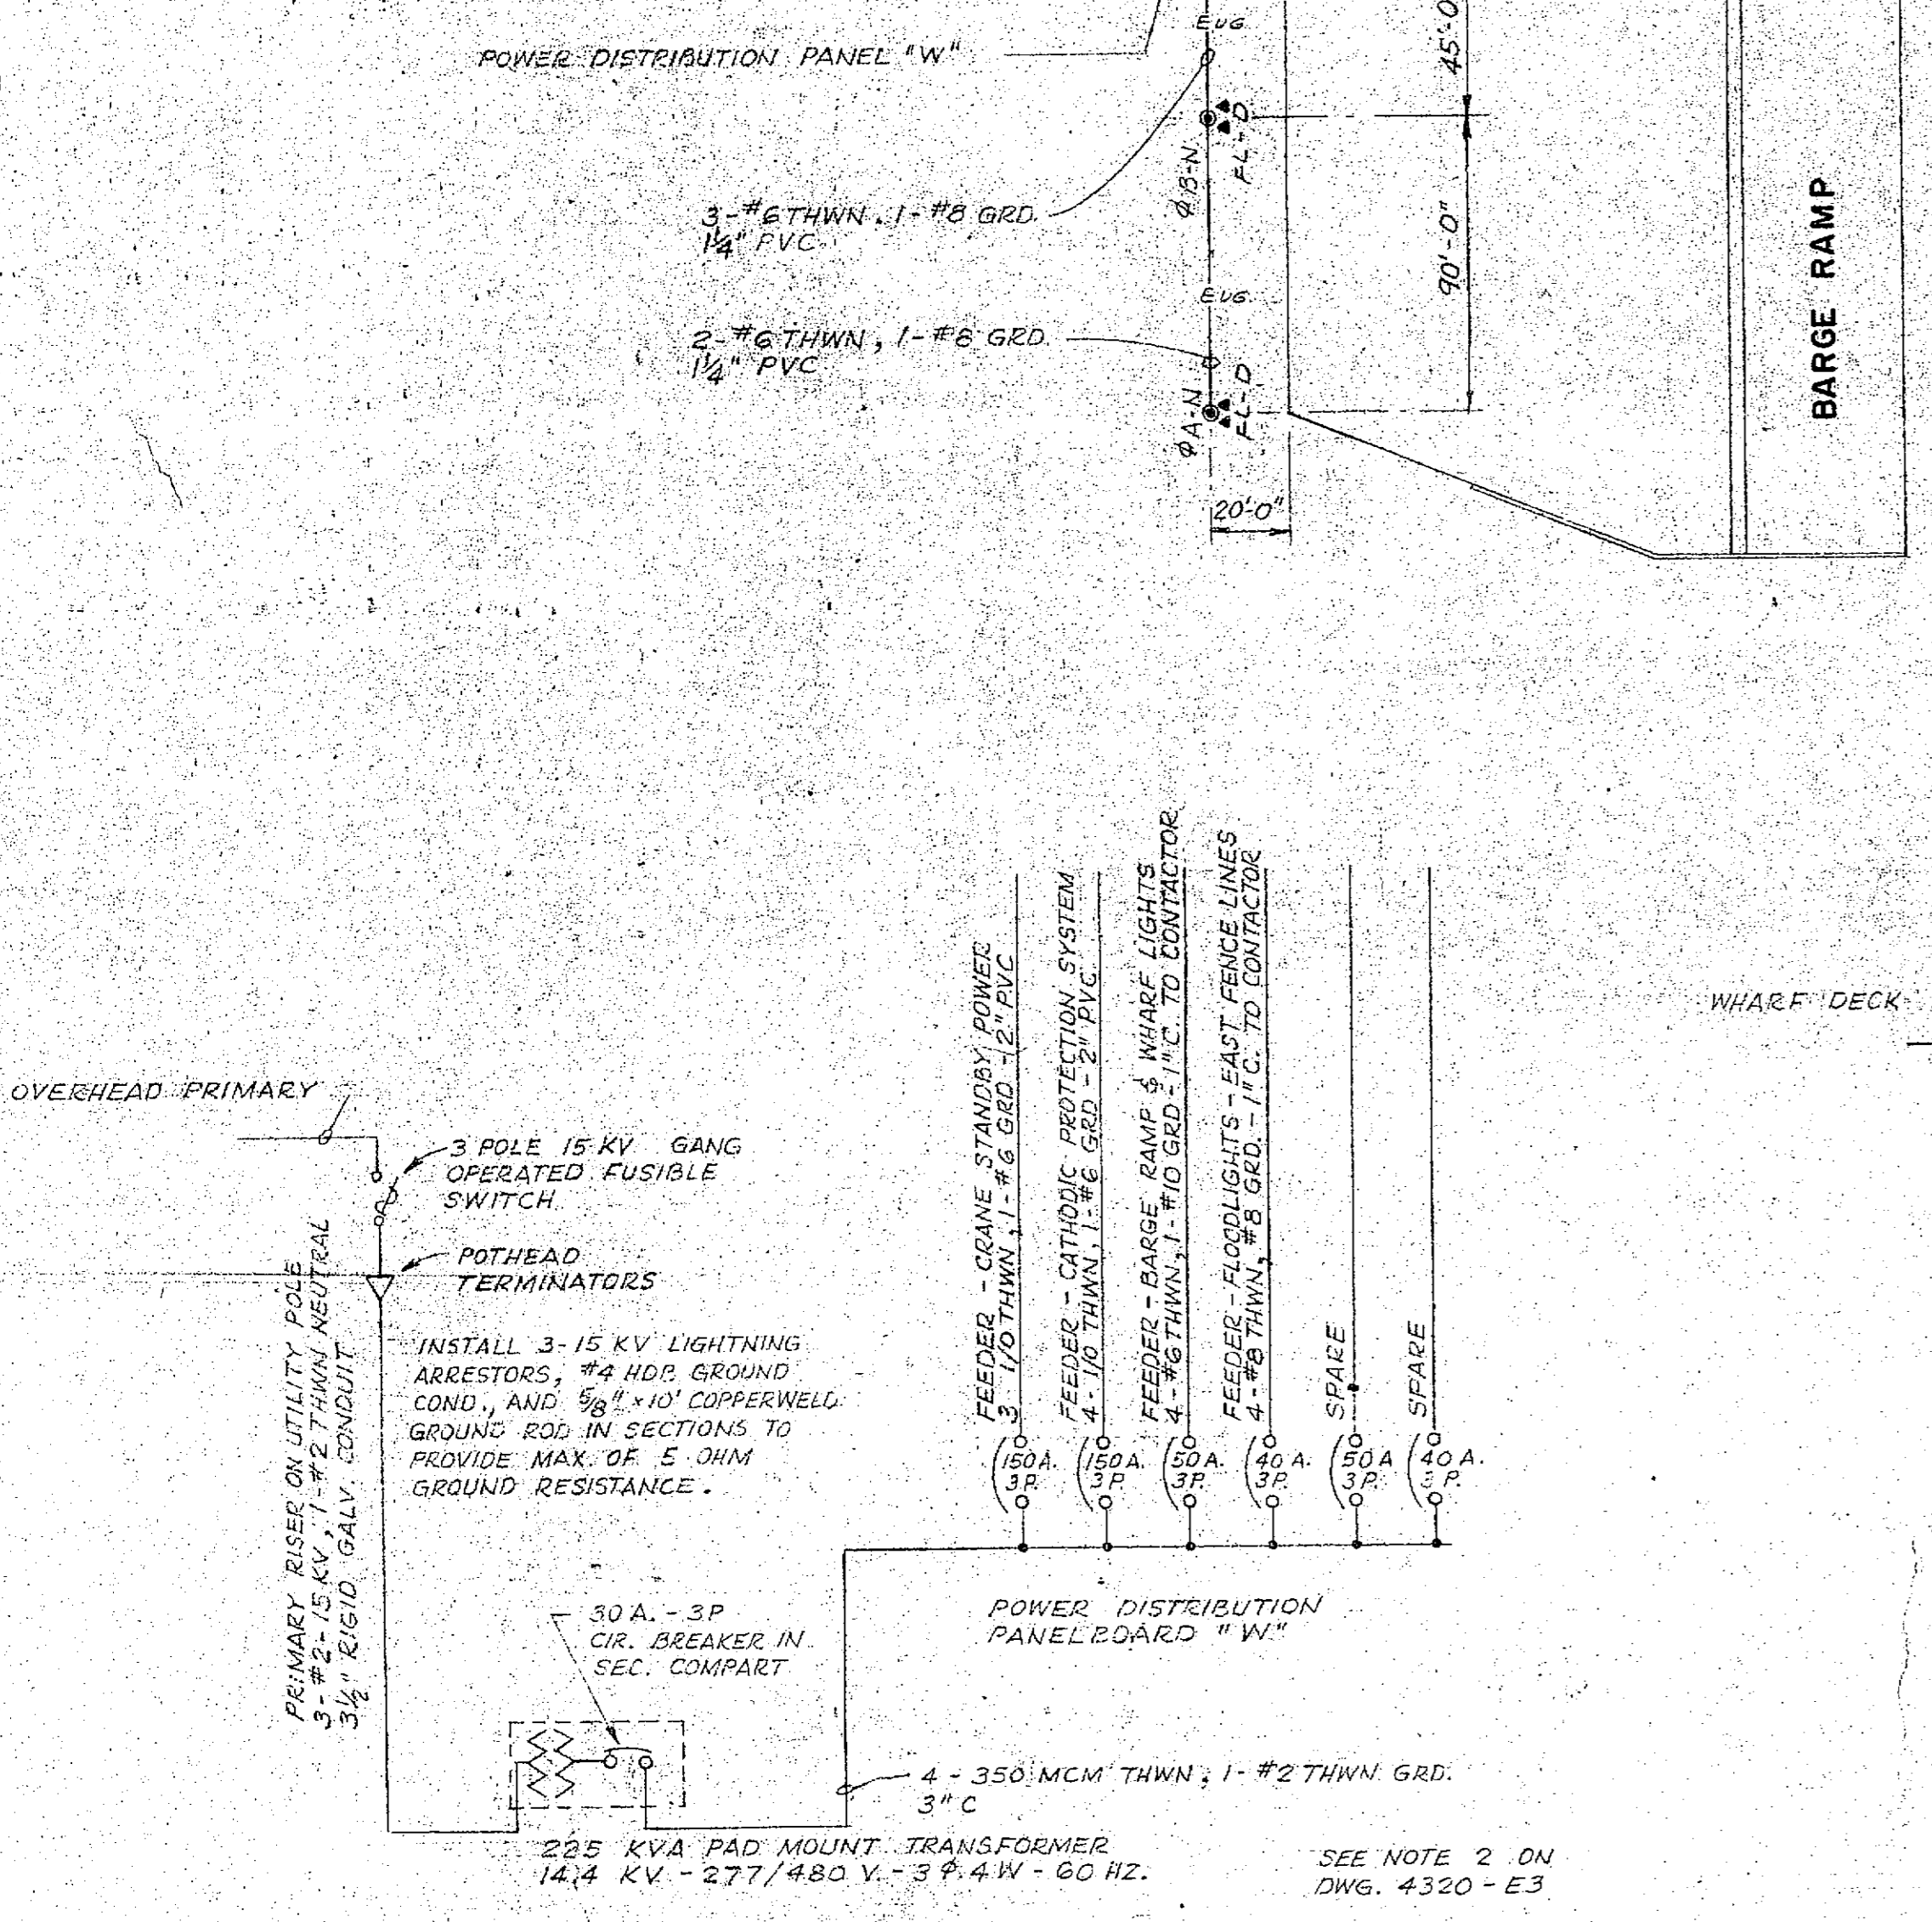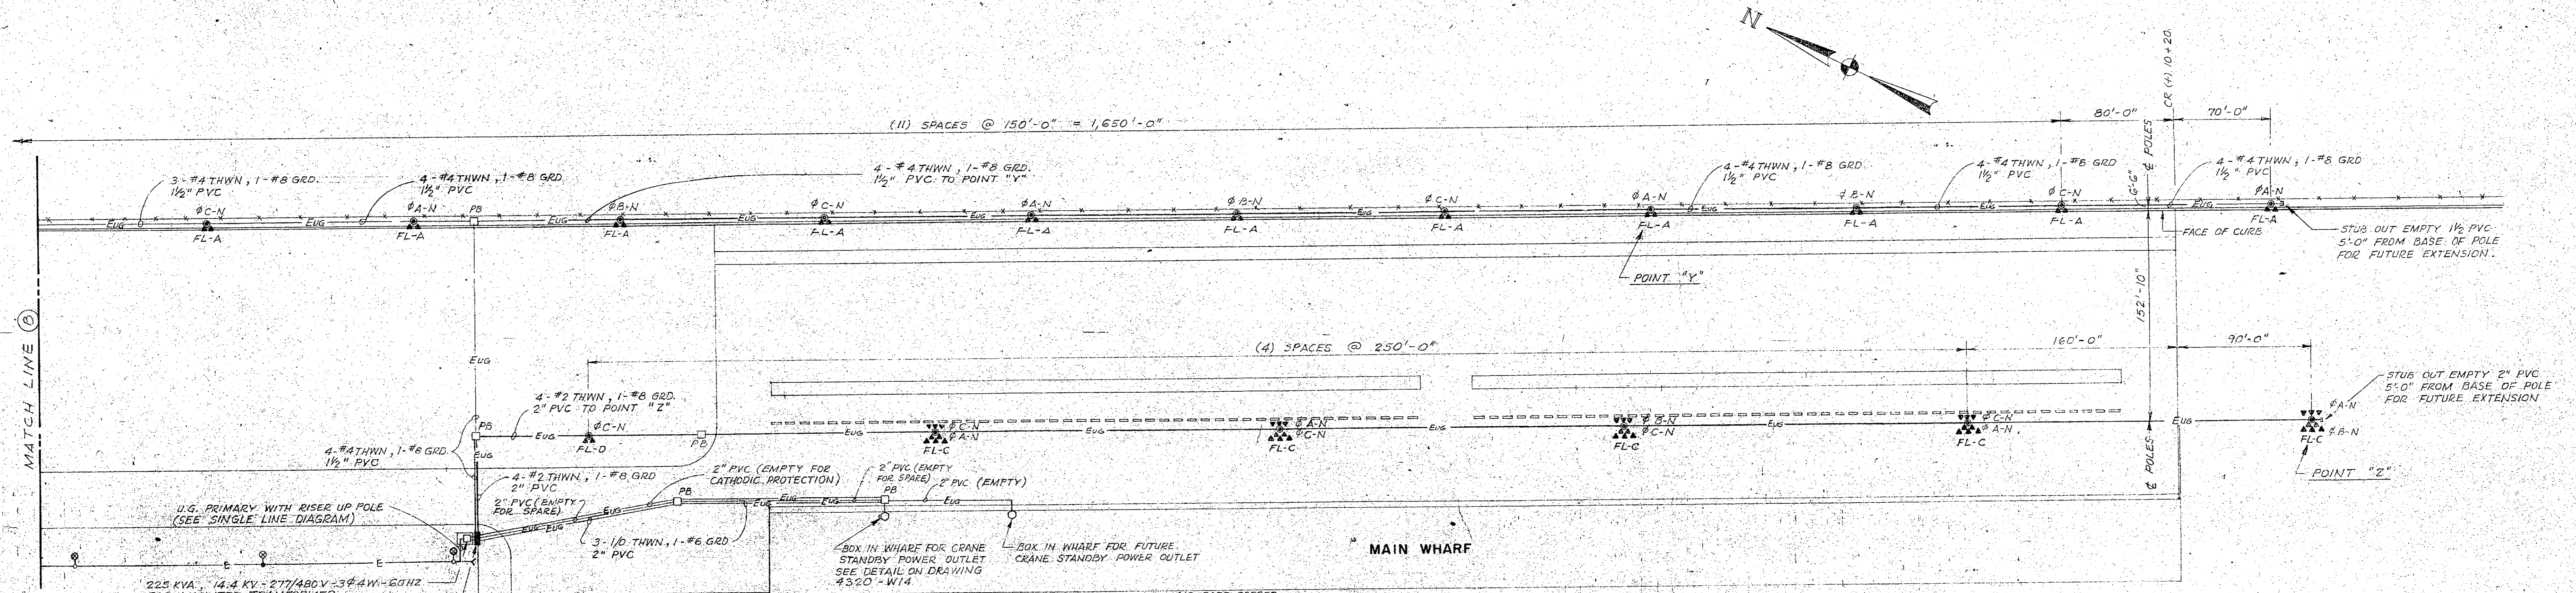

**SYMBOL LEGEND FOR POWER DISTRIBUTION PANEL**

SYMBOL	DESCRIPTION
"W"	POWER DISTRIBUTION PANEL 480/277 V, 4 W, 3 P WITH 400 A - 3P MAIN LUGS ONLY, 2-150 A - 3P, 2-50 A - 3P, 2-40 A - 3P BRANCH CIRCUITS. SQUARE D I-LINE IN WEATHERPROOF ENCLOSURE.
"A"	LIGHTING CONTACTOR FOR EAST FENCE LINE FLOODLIGHTS ASCO CAT. NO. 925PR9, 30A - 480 V - 3P-60 HZ WITH 277 V. COIL, MOUNTED IN NEMA II ENCLOSURE.
"B"	LIGHTING CONTACTOR FOR WHARF AND BARGE RAMP FLOODLIGHTS. ASCO CAT. NO. 926PR9, 60 A - 480 V - 3P-60 HZ WITH 277 VOLT COIL, MOUNTED IN NEMA II ENCLOSURE.
"S"	20 A - 1P - 277 VOLT BY-PASS TOGGLE SWITCH MOUNTED IN "FS" CONDULET WITH WATERTIGHT COVER.
"PE"	PHOTO ELECTRIC CONTROL TORK CAT. NO. 2102, 277 V. SEE EXTERIOR LIGHTING CONTROL DIAGRAM DWG. 4320-E1

- NOTES**
- CONTRACTOR TO VERIFY ALL MOUNTING DIMENSIONS.
  - PIPE SLEEVES & POST TO BE HOT DIPPED GALVANIZED AFTER FABRICATION.

REV.	DATE	DESCRIPTION
C	10-15-80	REVISED FIXTURES, LAMPS & POLES
B	2-22-80	MISCELLANEOUS REVISIONS
A	1-18-80	DRAWING COMPLETE

**HESS OIL VIRGIN ISLANDS CORP.**

**HESS**

ST. CROIX U.S. VIRGIN ISLANDS

<b>EWING, CAMPBELL &amp; GOTTLIEB</b> CONSULTING ENGINEERS	<b>CONTAINER PORT</b>
MOBILE NEW ORLEANS	OUTSIDE ELECTRICAL
Checked By: EMD Approved: [Signature] V.I. PERM. NO. T-169	AREA C
Scale: 1" = 50'	<b>DRAWING NO. 4320 - E4</b>

**SINGLE LINE DIAGRAM**

**CRANE STANDBY POWER OUTLET**

**SIGN DETAIL**



**BID DOCUMENT PICK-UP**

**Sign-in Sheet**

**OPERATIONAL AREA PAVEMENT REHABILITATION**

WILFED "BOMBA" ALLICK MARINE PORT  
 St. Croix, U.S. Virgin Islands  
 VIPA CER Project No. C2014-49

Location: Henry E. Rohlsen Airport  
 Virgin Islands Port Authority  
 Purchasing Department

Owner: Virgin Islands Port Authority

Print Name	Company Name	Contact Phone	Email
Chanda Coui	Marco St. Croix	(340) 778-1035	marcostcroix@gmail.com
Eason Jeffers	Quantum Vision Const.	(340) 227-1191	EASONJEFFERS@QUANTUMVISIONCONSTRUCTION.COM
JACQA HAYMAN	ATC, LLC	340-478-2100	JACQUAHAYMAN@ATC.VI
GEORGE LEPES	VI PAVING	778-5220	VI PAVING . com
Kirwyn Figaro	Eleven Constr.	340.513.8722	KirwynFig@gmail.com
RICARDO NATER	ATC.	787-312-7621	RNATER@AIREKO.COM



**PRE-BID CONFERENCE**

**Sign-in Sheet**

**Operational Area Pavement Rehabilitation**

**WILFRED "BOMBA" ALLICK MARINE FACILITY  
St. Croix, U.S. Virgin Islands  
VIPA CER Project No. C2014-49**

**Location:** Henry E. Rohlsen Airport  
Virgin Islands Port Authority  
Terminal Conference Room

**Time:** 11:00 AM

**Date:** Thursday, January 12, 2017  
**Owner:** Virgin Islands Port Authority

Print Name	Company Name	Contact Phone	Email
VANIS AURELLIENS	VIPA	778.3757	vaurelien@viport.com
FRITZGERALD BOEZEM	VIPA	778.1012	fboezem@viport.com
Kerwyn Augustin	MARCO	340-778-1035	marcosterdix@gmail.com
Monique Hendricks	VIPA	778-9696	mhendricks@vipa.com
Shawn Baptiste	marco	513-2218	marco.waterbe@doj.gov
Franklyn Victor	Running Coast.	514 2788	Fymaint@Hotmail.com
Mark Grimes	Custom Builders	775-2605	MGrimes@custombuilders-vi.com
Rafael Hernandez	A.T. Construction	(787) 615-1924	rahernandez@airfoto.com